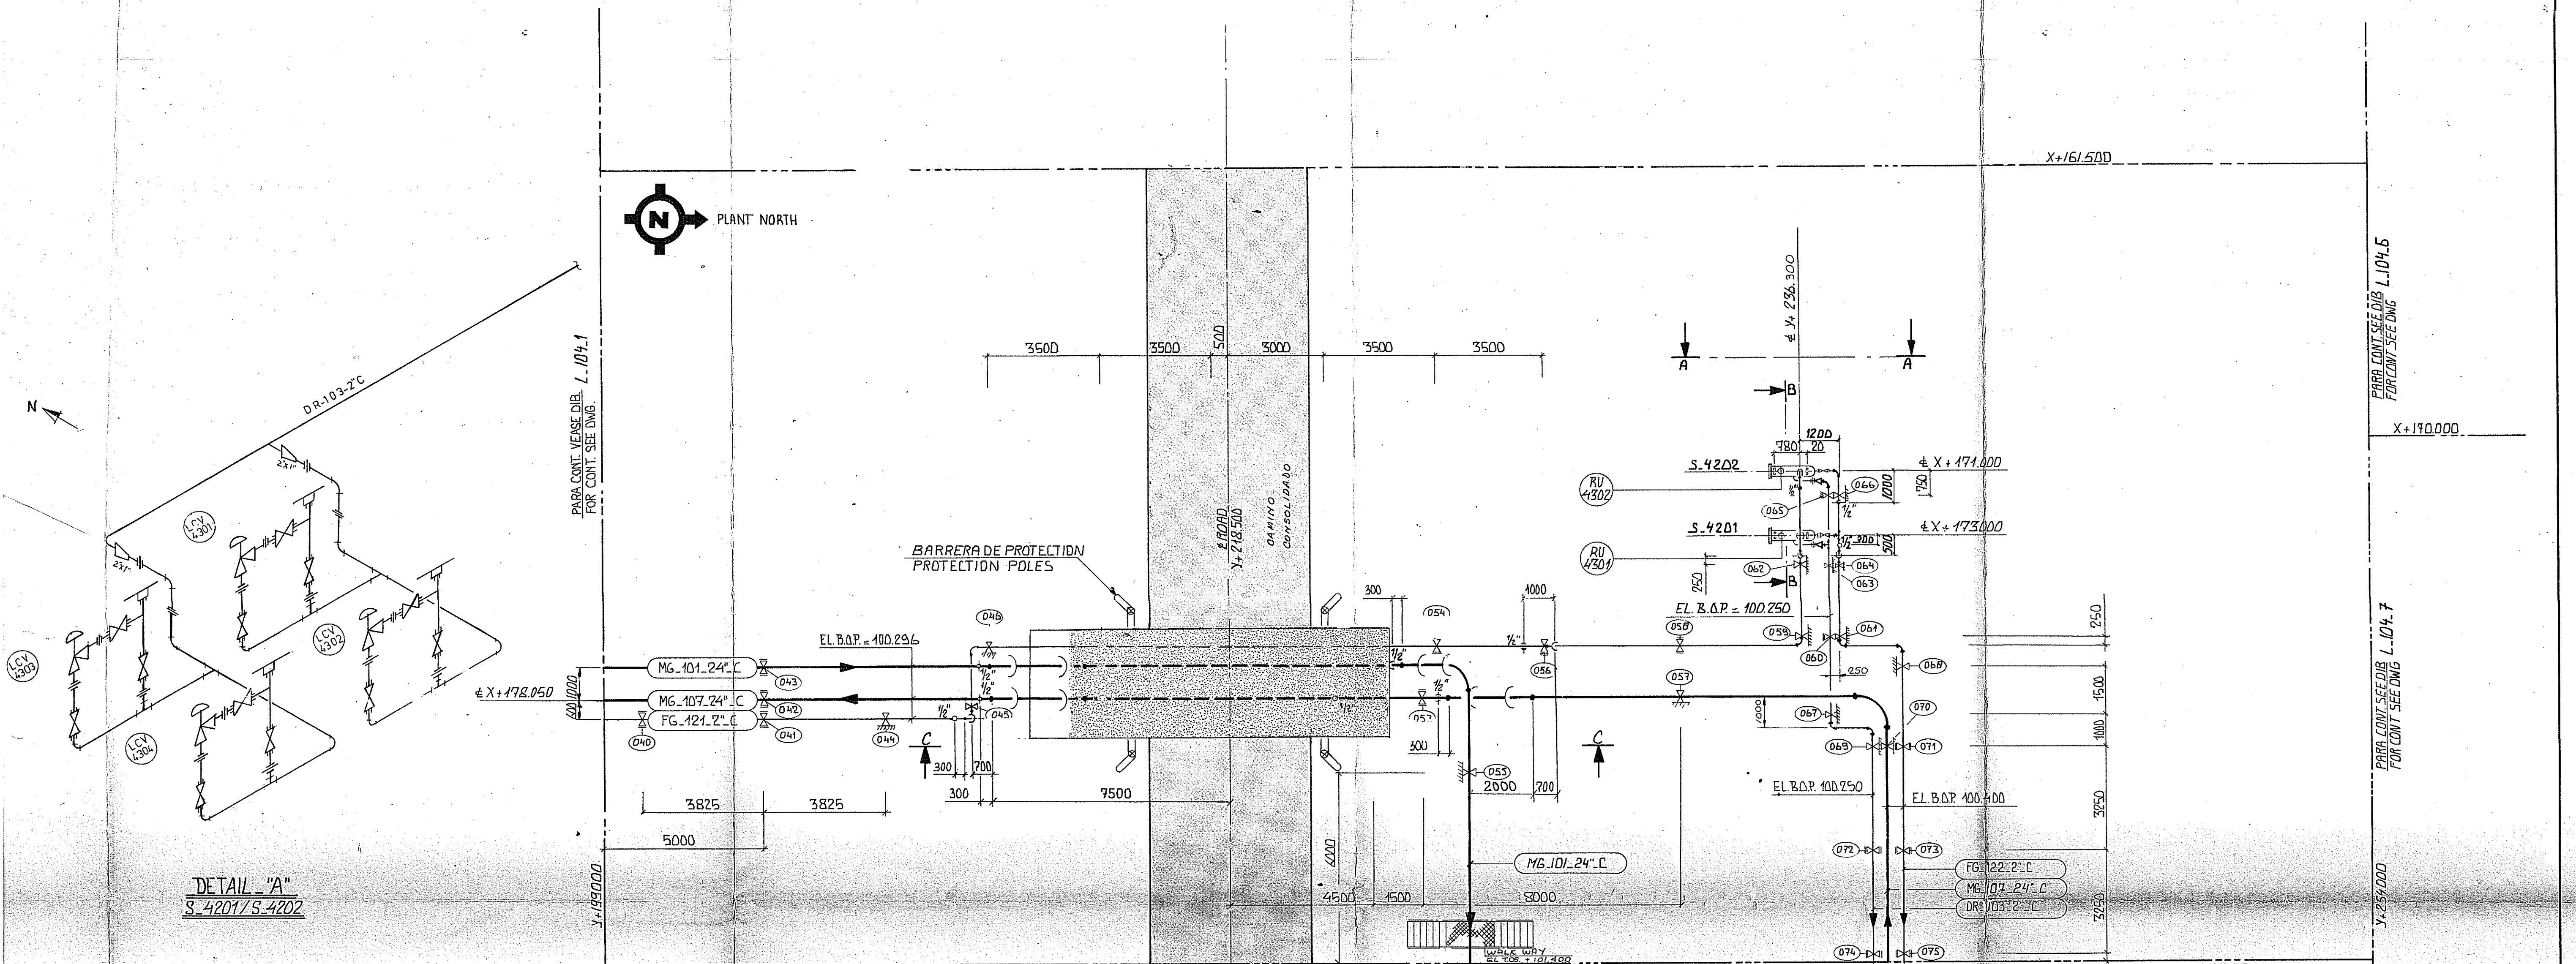


COMENTARIO REMARKS		DIBUJOS DE REFERENCIA REFERENCE DRAWINGS		CONFORME A OBRA A OBRA	
DIMENSIONES EN MM. SALVO DADO DE OTRA MANERA DIMENSIONS IN MM. UNLESS STATED OTHERWISE ALT. DE TERR. GRADE = 100.000		INSTRUMENT INDEX		FECHA	
SUPERFICIAL OVERGROUND		J-104-12		PLAN DE TUBERIA ZONA_2 PIPING PLAN AREA_2 C.S. LA CARLOTA	
SUBTERRANEO UNDERGROUND		SYMBOLS DE BASICOS PARA PLANOS DE TUB. BASIC SYMBOLS FOR PIPELINE DWGS.		cliente: consorcio gasoducto centro-oeste s.a.	
		DIAGRAMA SISTEMA DE GAS PRINCIPAL P&I DIAGRAM MAIN GASSYSTEM		comite: gas del estado	
		DIAGRAMA SISTEMA DE GAS PARA GEN. P&I DIAGRAM FUEL GASSYSTEM FOR GEN.		dib. dwn. J.J.G.	
		DIAGRAMA SISTEMA DE DRENAJE P&I DIAGRAM DRAIN SYSTEM		escala: 1:100 1:25	
		PLAN LLAVE (GUIA DE ZONAS) KEY PLAN		proy. no.: 2018	
		PLAN DE TUBERIA ZONA_1 PIPING PLAN AREA_1		tamano: A1	
		PLAN DE TUBERIA ZONA_3 PIPING PLAN AREA_3		dibujo no.: L.104.2	
		PLAN DE TUBERIA ZONA_6 PIPING PLAN AREA_6		rev.: 2	
		PLAN DE TUBERIA ZONA_7 PIPING PLAN AREA_7			
		LISTA DE LINEAS ESPECIFICADAS LINE SCHEDULE LIST			
		LIST OF SUPPORT LOADS			
		MATERIALIST MAIN GASSYSTEM			
		MATERIALIST FUEL GASSYSTEM			
		MATERIALIST DRAIN SYSTEM			
		MATERIALIST EQUIPMENT			
		CONEXION DE 1/2" 3/4" 1" 1 1/2" 2" 3" 4" 6" 8" 10" 12" CONNECTION DWG.			
		FUEL GAS SEPARATOR			
		EQUIPMENT LIST			